



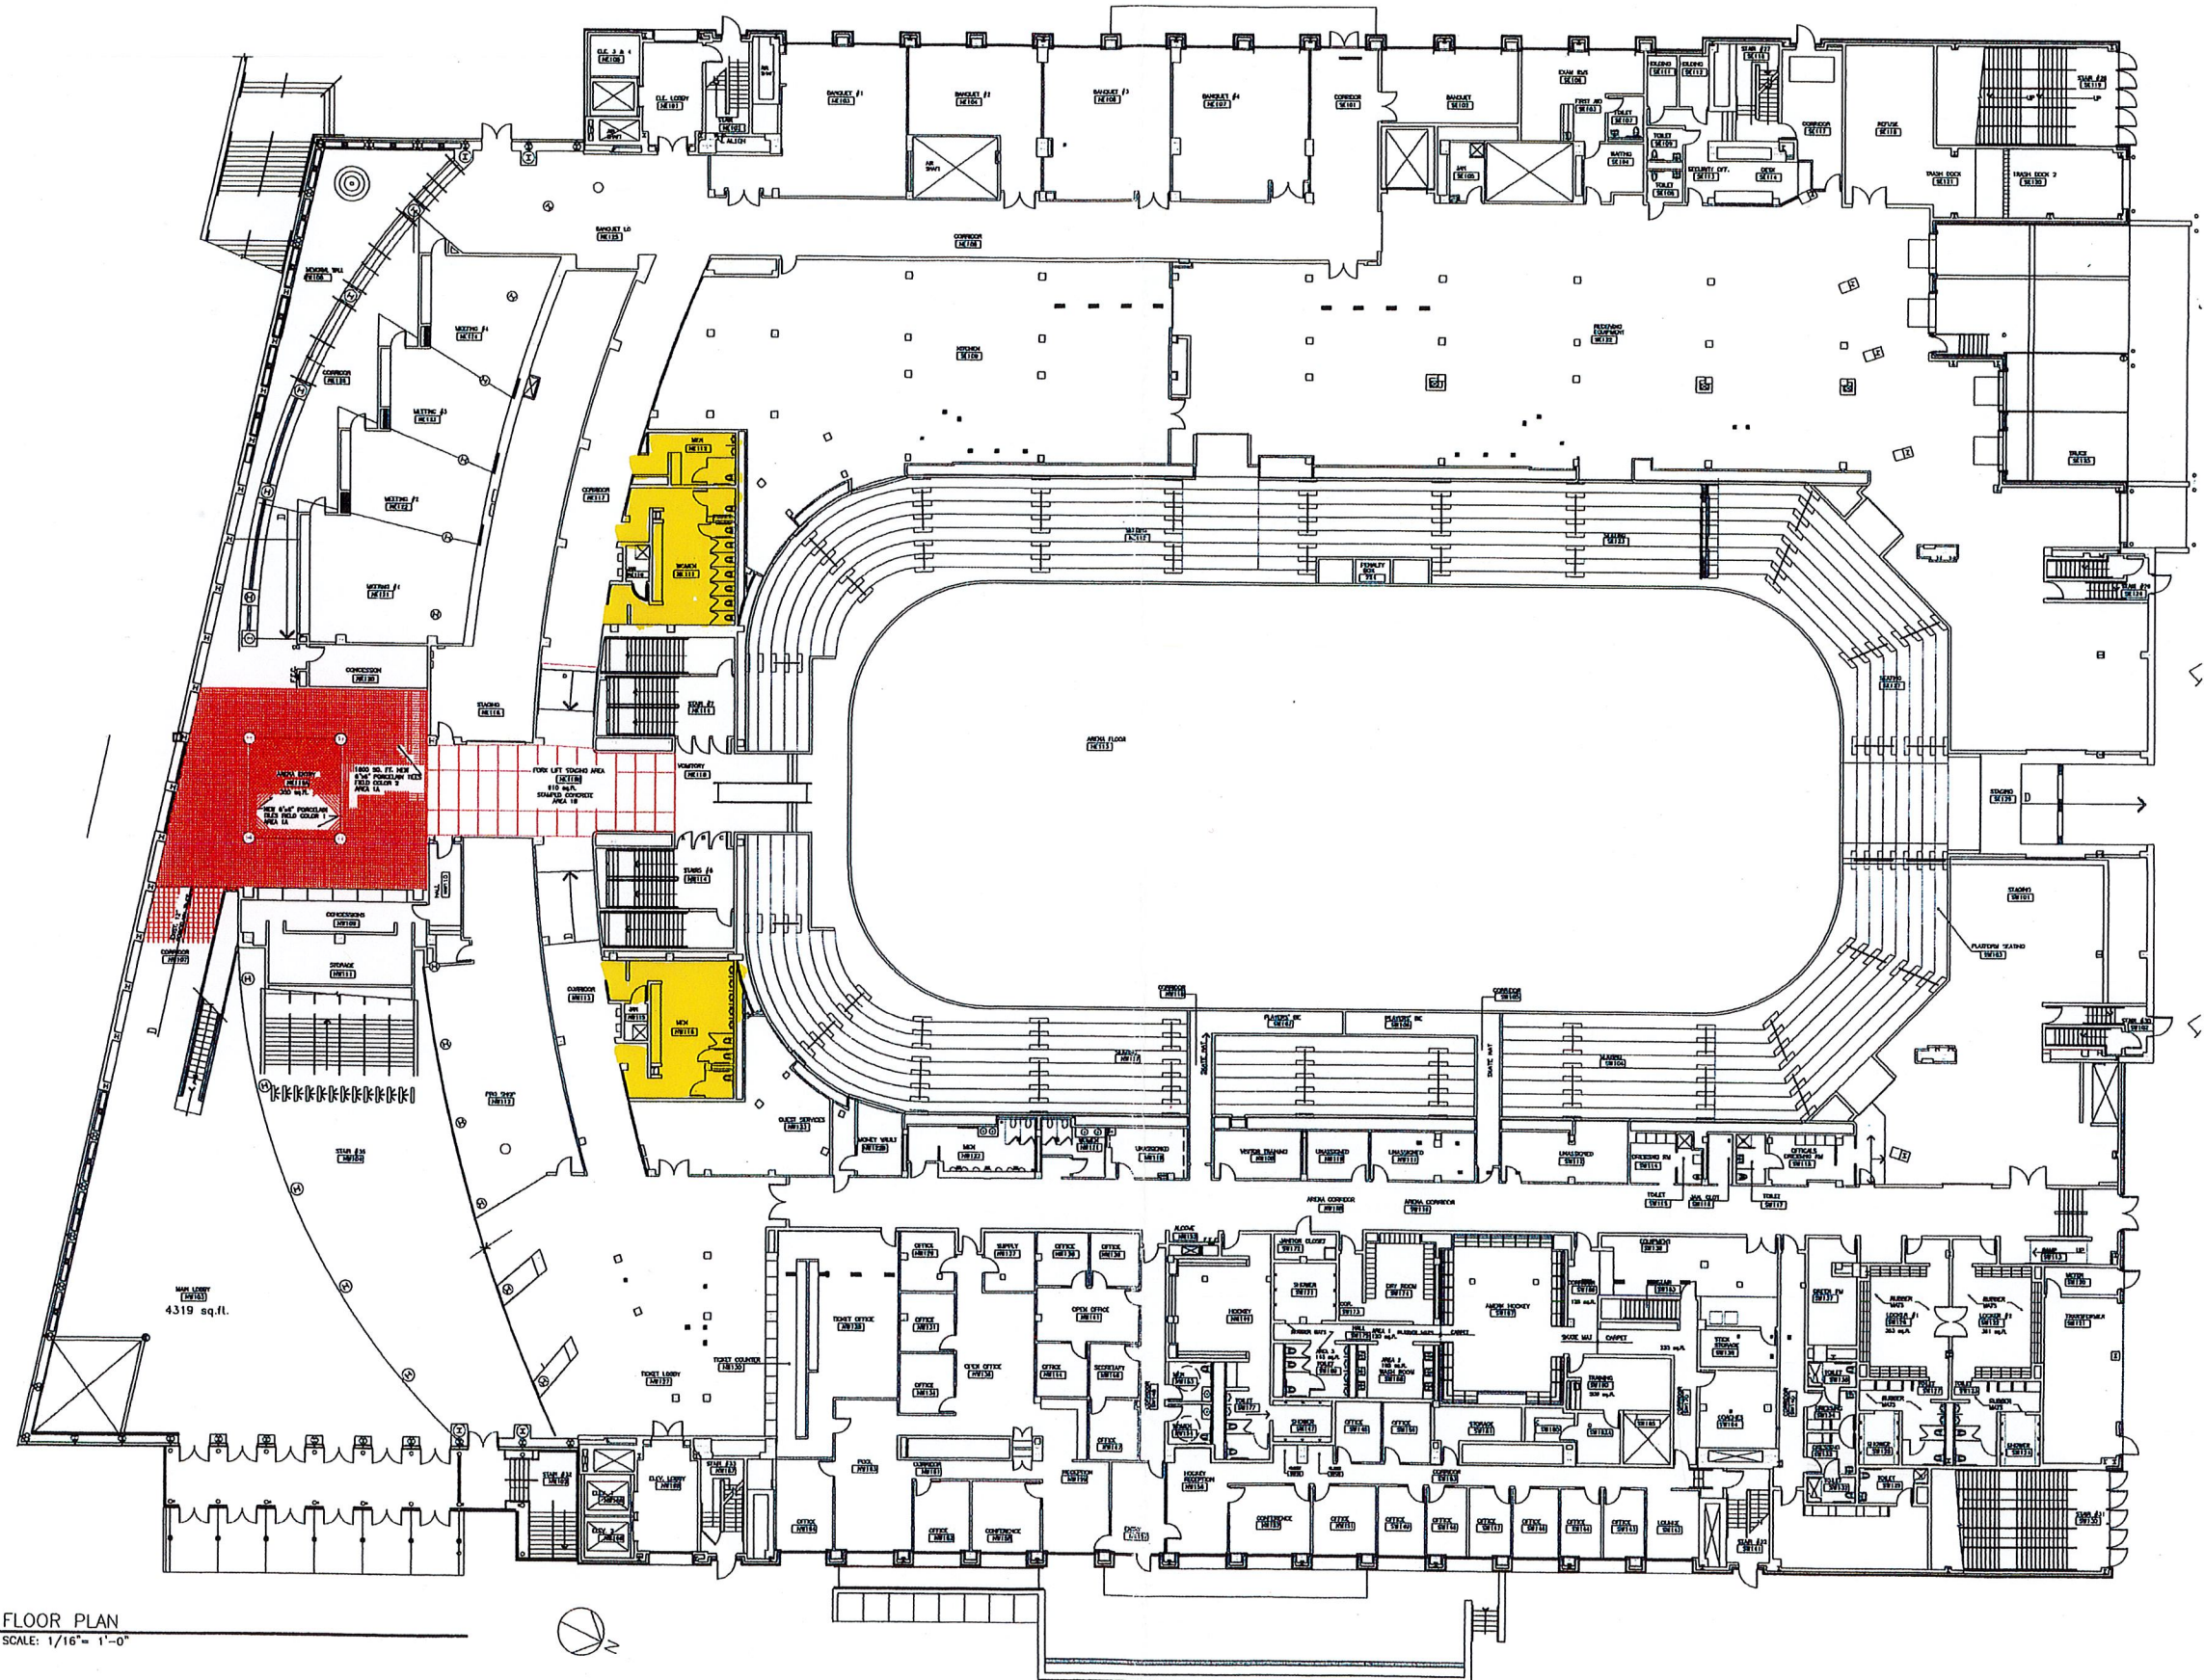
C:\PROJ\ARCH\CUSTOM - PLEASE LEAVE TEMPFILES\ROCHESTER\TEMPFILES\BASE-2011.DWG A-F 12/7/2010 10:23:42 AM

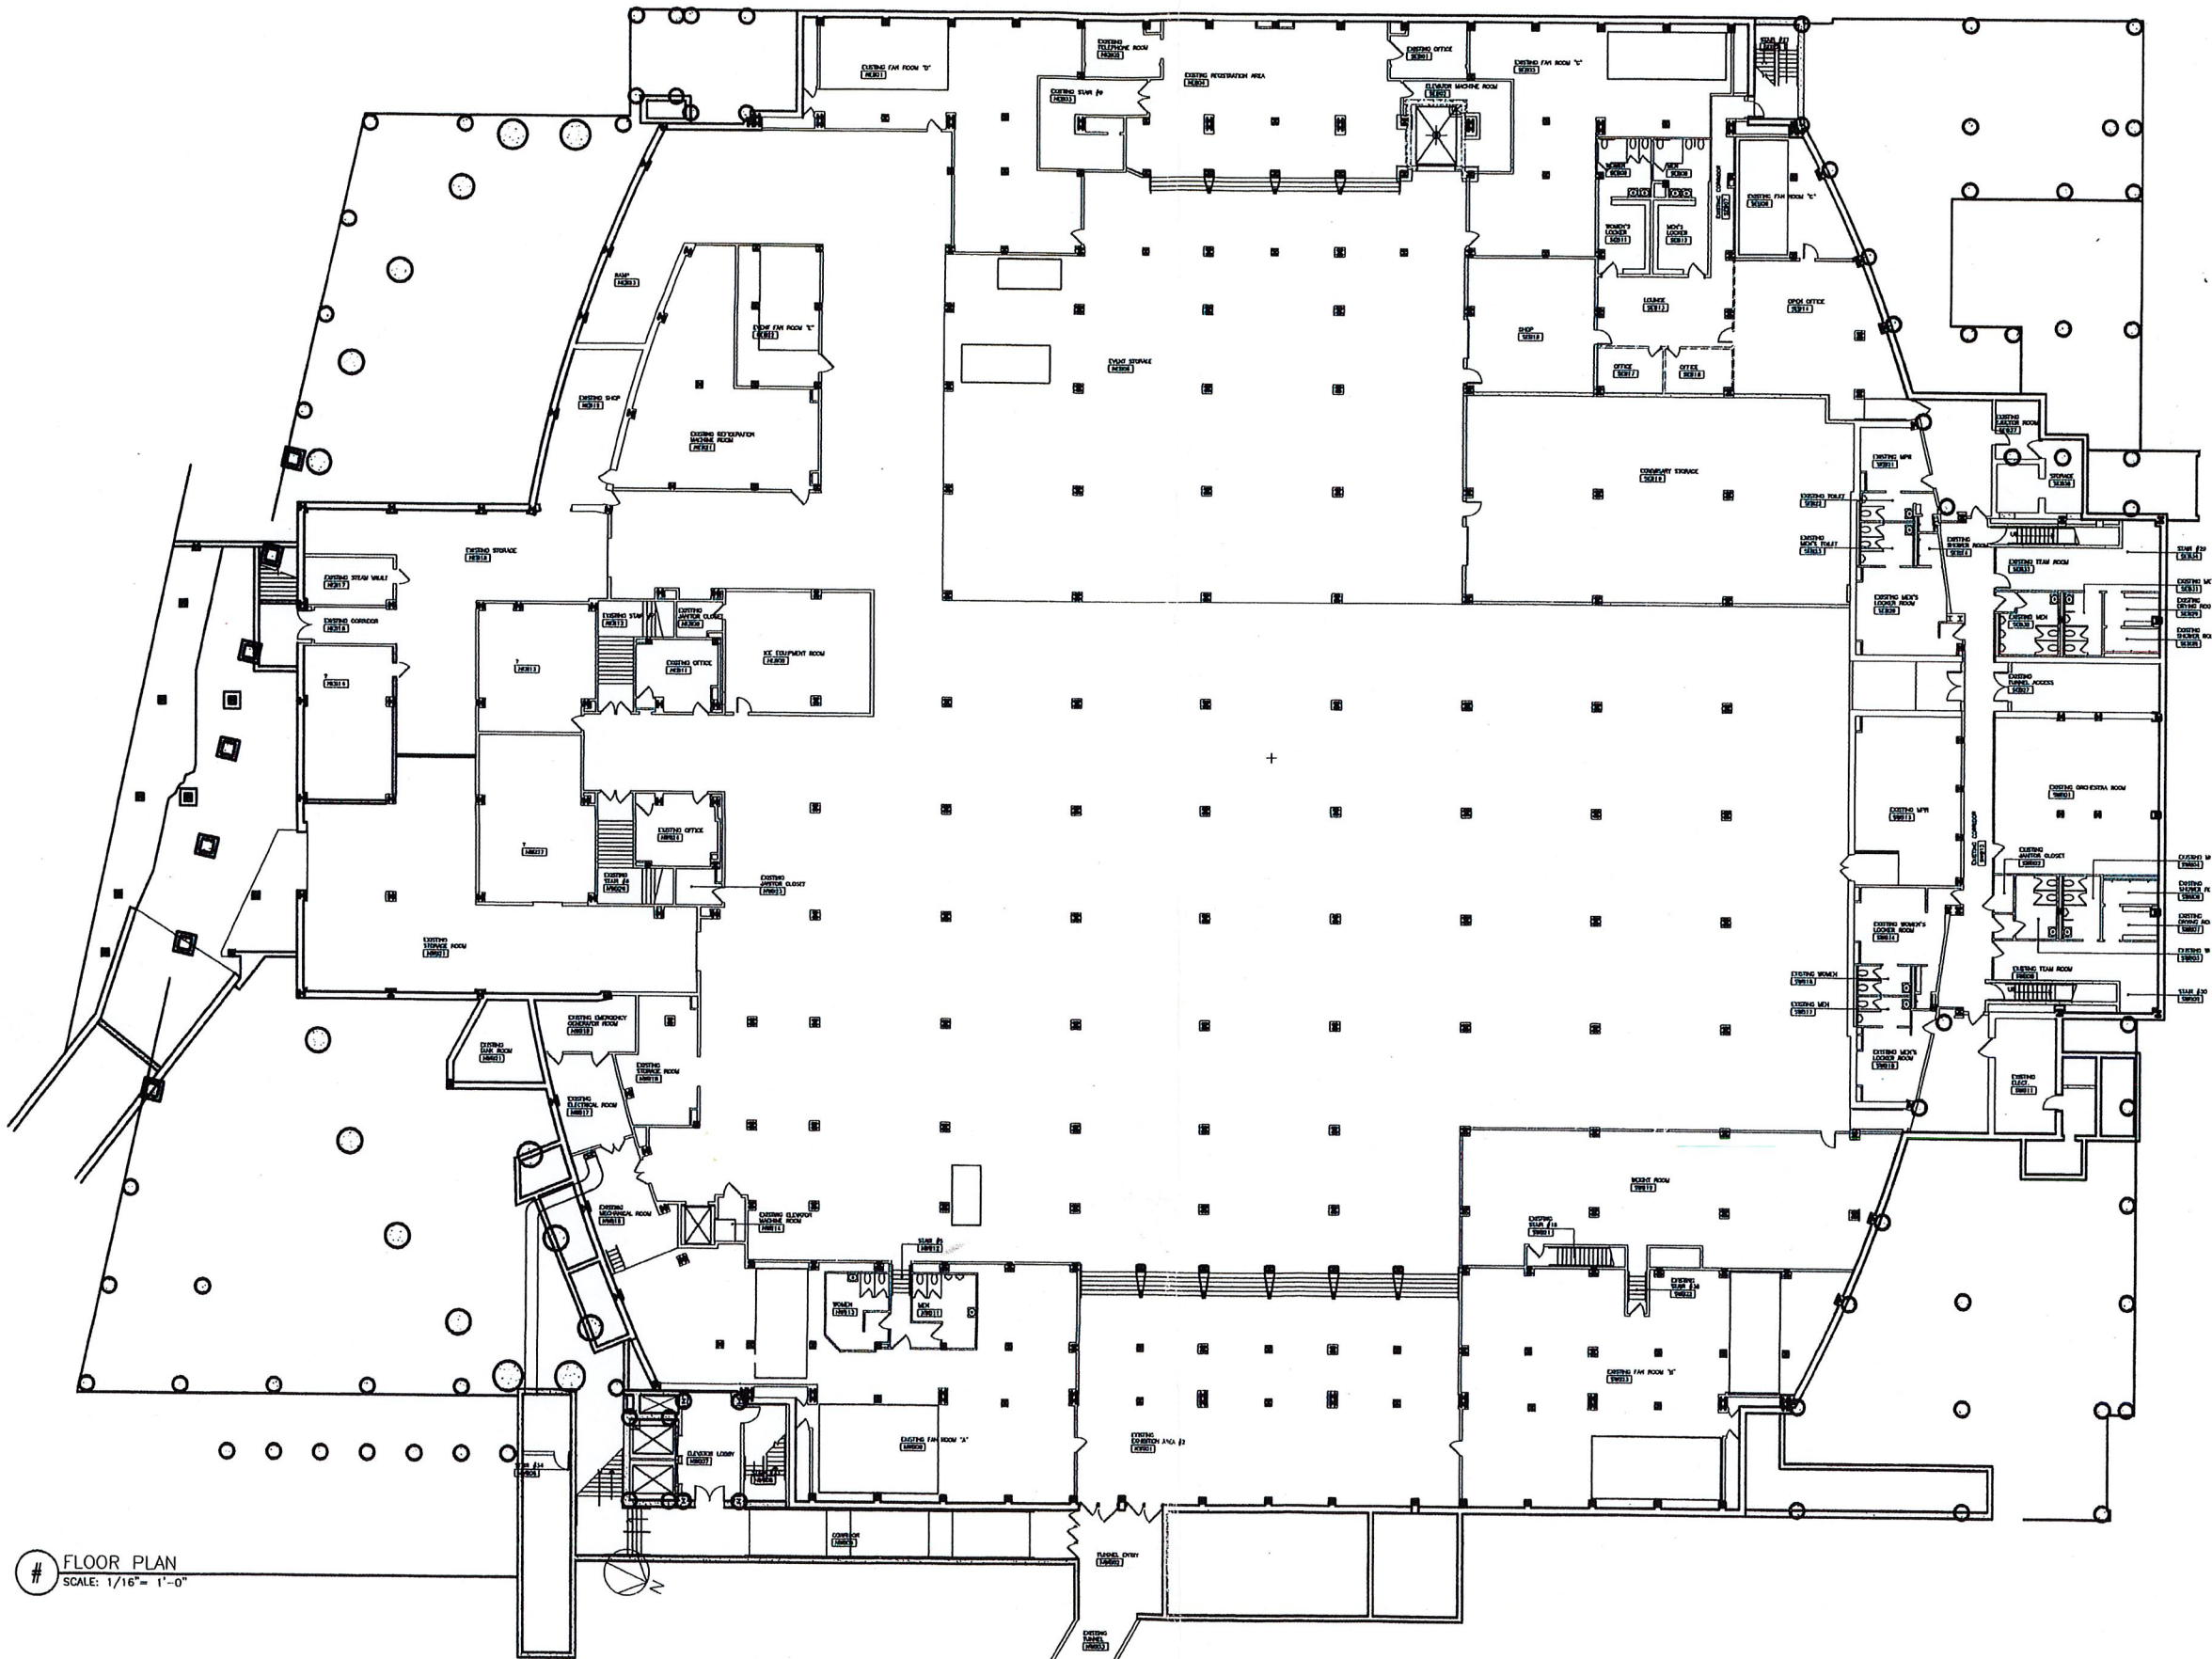

FLOOR PLAN
SCALE: 1/16" = 1'-0"

 City of Rochester Department of Environmental Services Bureau of Architecture and Engineering Architectural Services Division		ARCHITECT'S NAME VINCENZO GIORDANO, PA	
PROJECT: WAR MEMORIAL		ARCHITECT IN CHARGE VINCENZO GIORDANO, PA	
ADDRESS: Rochester, NY 14618			
ISSUED	XX/XX/11	NO.	XXXXX
CHECKED	XXX	REVISIONS	
DRAWN	MAA	BY	DATE
DESIGN	XXX		
BUILDING NUMBER	9139		
PROJECT NO.	XXXXX		
DRAWING TITLE: BASEMENT LEVEL FLOOR PLAN			
DRAWING NO.: A-#			
# OF #			

G:\PROJ\ARCH\CAD\DWG\ACAD\JULIUSTON - PLEASE LEAVE THESE PLATES ROCHESTER TEMPLATES BASE-2011.DWT A-# 12.27.2010 10:23:45 AM




FLOOR PLAN
SCALE: 1/16" = 1'-0"

4319 sq. ft.

City of Rochester Department of Environmental Services Bureau of Architecture and Engineering Architectural Services Division		ARCHITECT'S NAME VINCENZO GIORDANO, PA	
PROJECT IN CHARGE MANAGING ARCHITECT		ADDRESS, Rochester, NY 146XX	
VAR MEMORIAL			
ADDRESS, Rochester, NY 146XX			
ISSUED	XX/XX/11	REVISIONS	BY
CHECKED	XXX		DATE
DRAWN	JMA		
DESIGN	XXX		
BLOC. NUMBER	P.39		
PROJECT NO.	XXXXX		
FLOOR PLAN			
DRAWING NO.			
A-#			
# OF #			

C:\PROJ\WAR\CONC\WCONC.DWG - P:\GE\BANK\TEMP\ROCHESTER\TEMP\WCONC-2011.DWG A-F 12/7/2010 10:23:42 AM

FLOOR PLAN
SCALE: 1/16" = 1'-0"

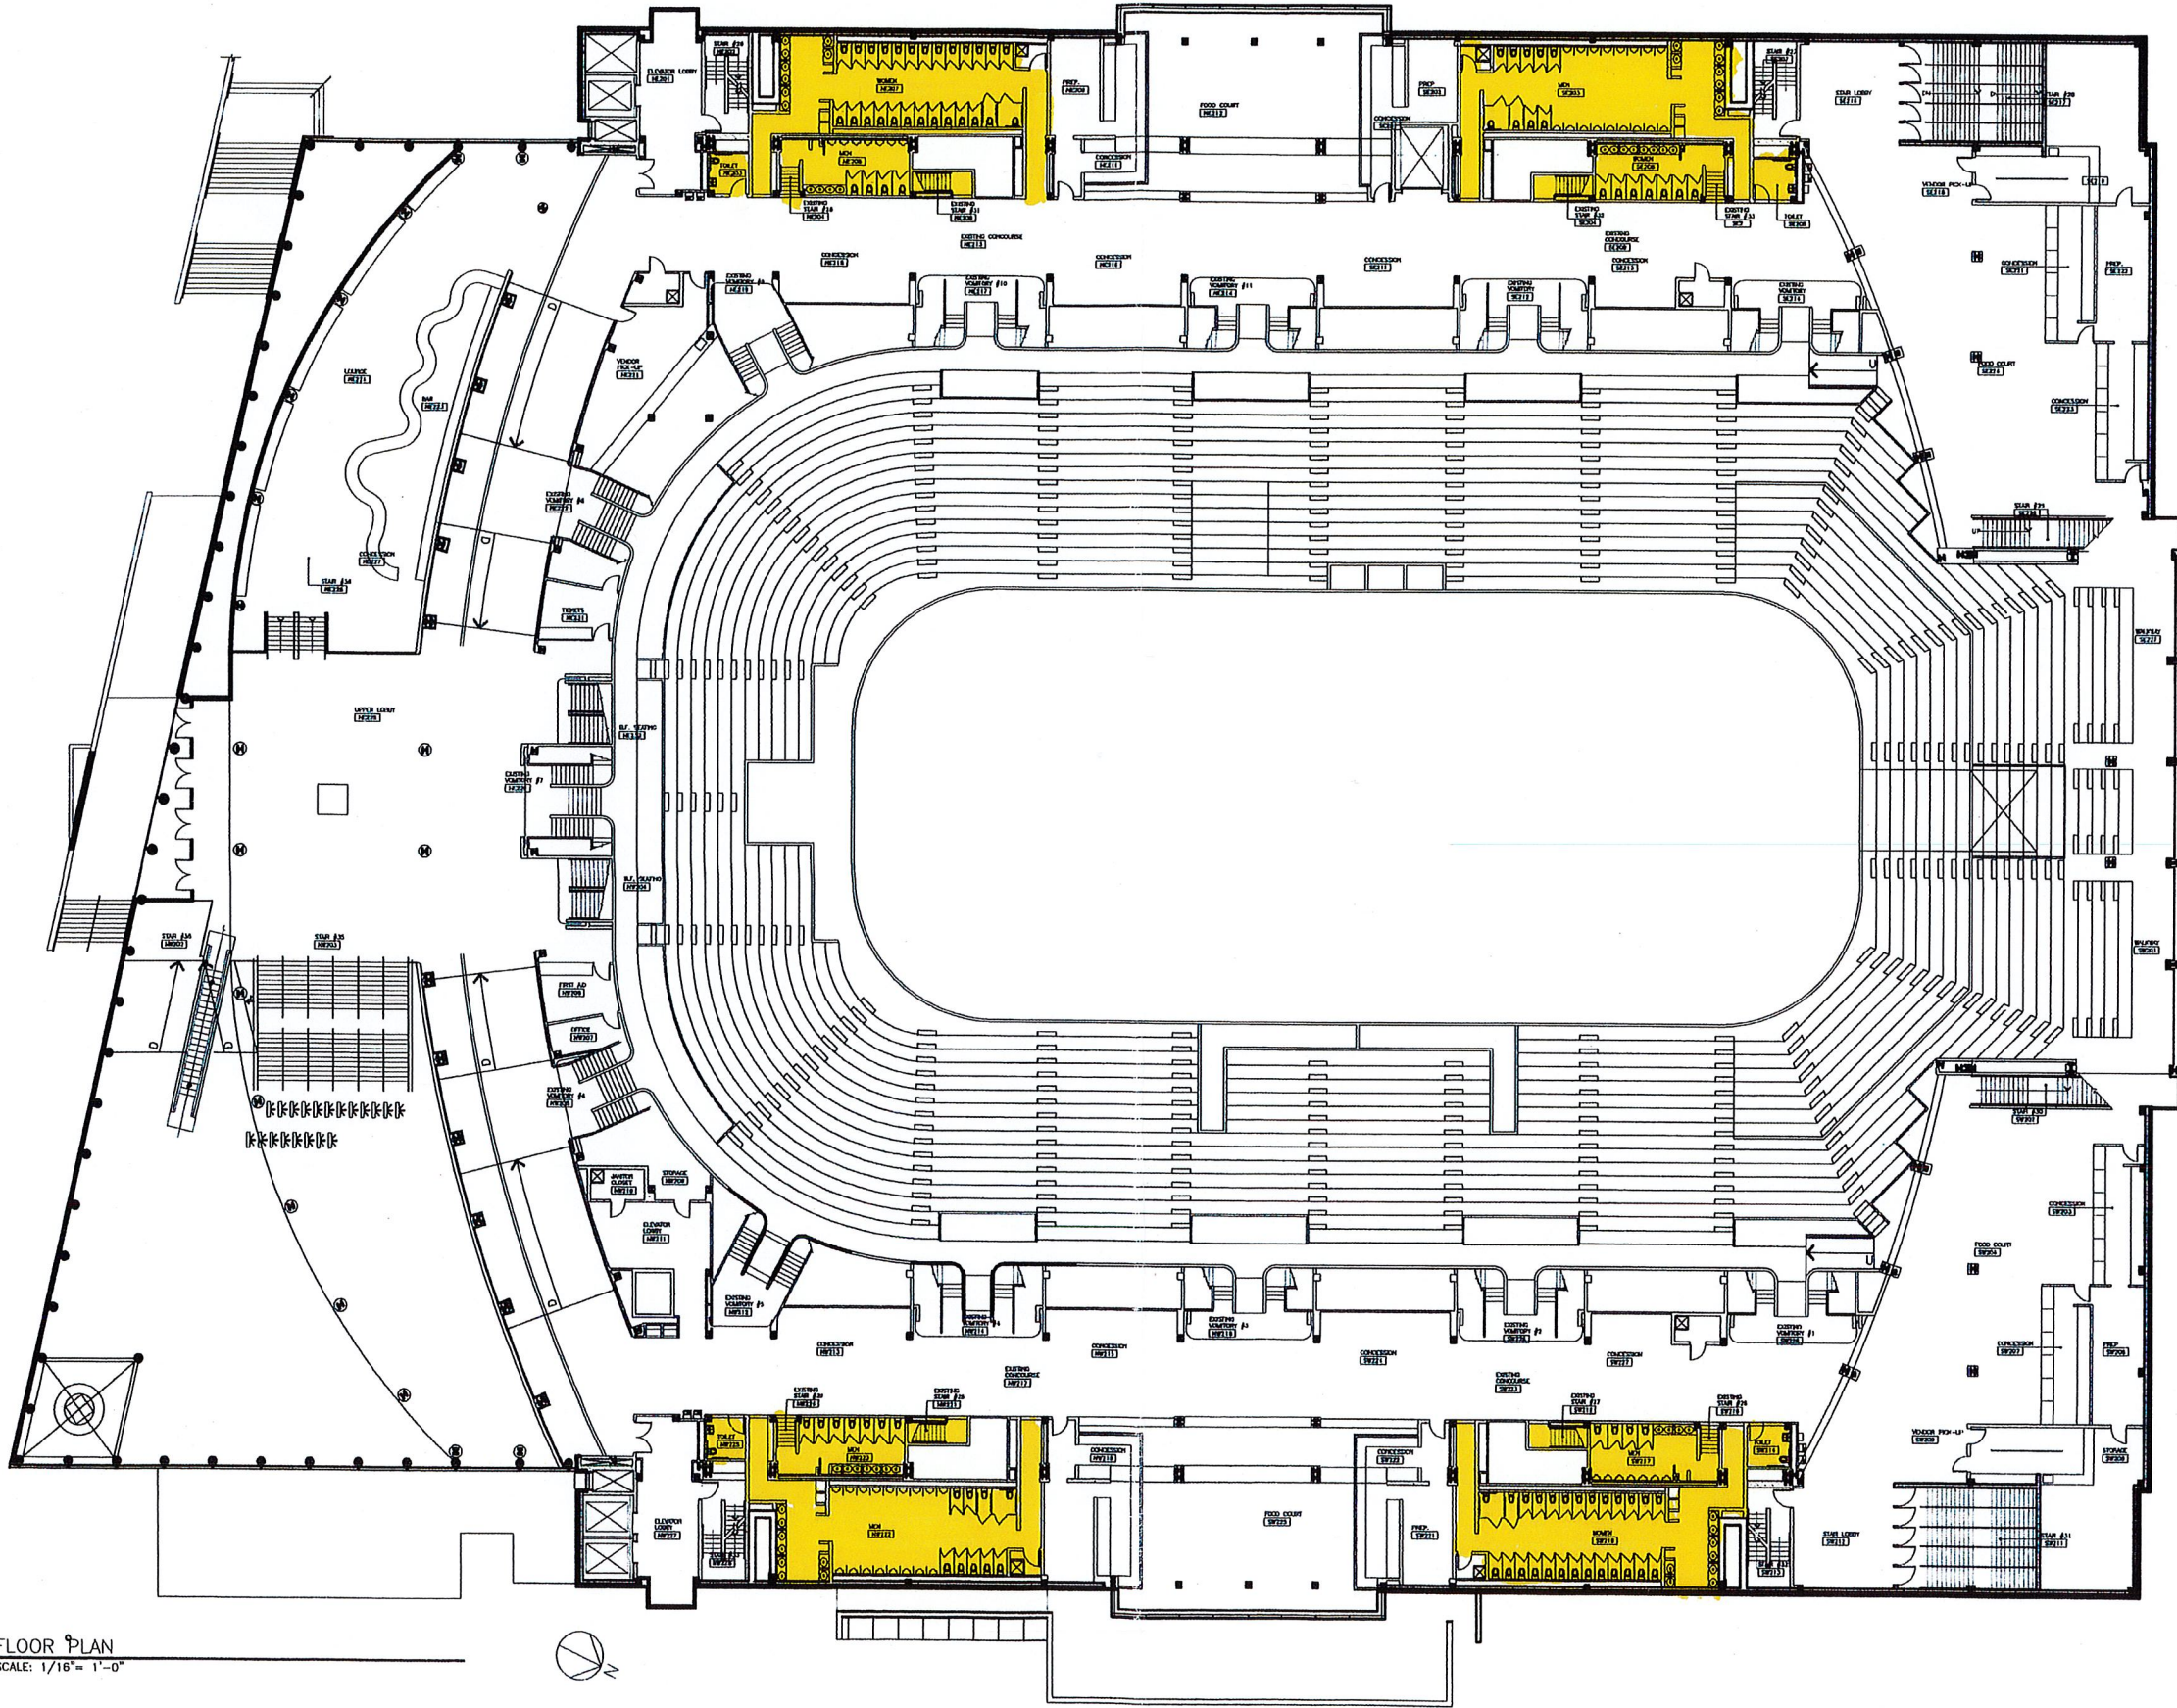

DRAWING TITLE:

CONCOURSE LEVEL
FLOOR PLAN

DRAWING NO:

A-#

OF

ISSUED: 12/7/11

CHECKED: XXX
DRAWN: MAA
DESIGN: XXX
E.L.C. NUMBER: 9.39
PROJECT NO.: XXXXX

PROJECT:

WAR MEMORIAL

ADDRESS: Rochester, NY 14618

City of Rochester
Department of Environmental Services
Bureau of Architecture and Engineering
Architectural Services Division



ARCHITECT IN CHARGE: MANSONG ARCHITECT
ARCHITECT'S NAME: VINCENZO GIORDANO, PA

BY:


REVISIONS:

NO.

DATE

C:\PROJ\ARCH\LOAD\ACADISTM - PLEASE LEAVE TEMPLATES\ROCHESTER_TEMPLATES\BASE-2011.DWT A-# 12/7/2010 10:23:42 AM

FLOOR PLAN
SCALE: 1/16" = 1'-0"

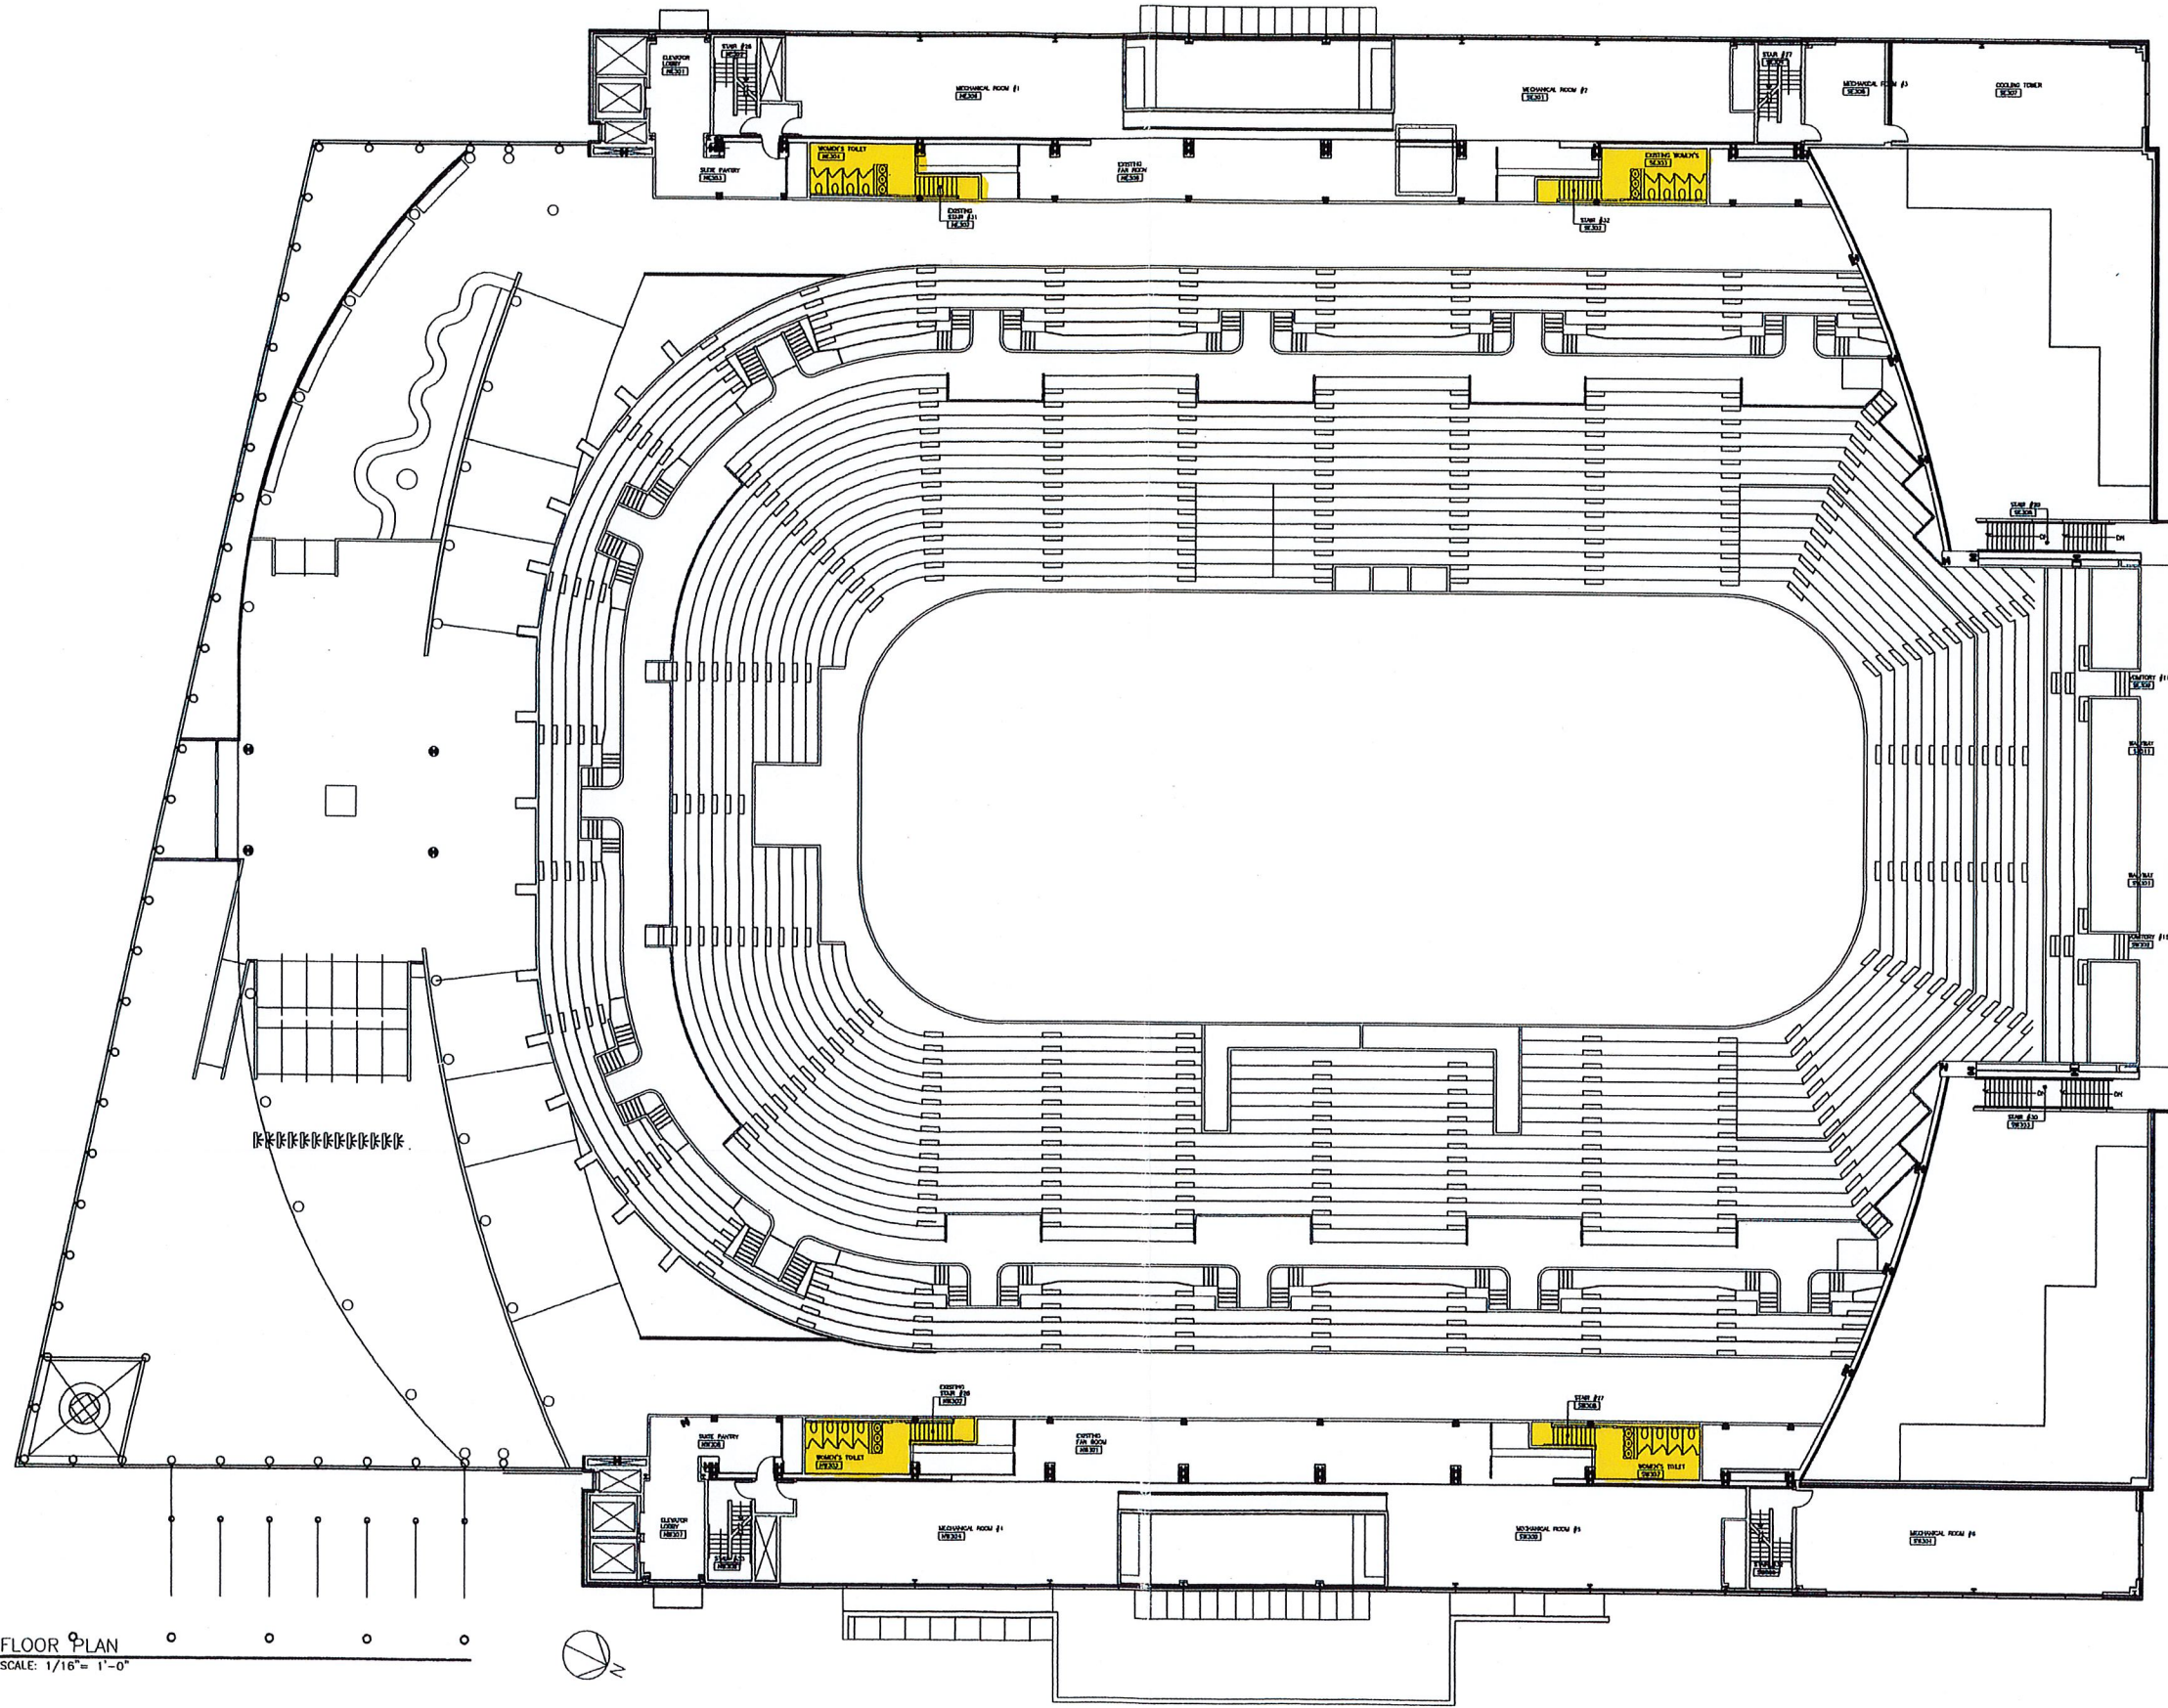

DRAWING TITLE:

LEVEL 3
FLOOR PLAN

DRAWING NO:

A-#

OF

ISSUED: 02/04/11

CHECKED: xxx
DRAWN: MAM
DESIGN: xxx
BLDG. NUMBER: 0.39
PROJECT NO.: XXXXX

NO. REVISIONS BY DATE

PROJECT:

WAR MEMORIAL
ADDRESS: Rochester, NY 14618




City of Rochester
Department of Environmental Services
Bureau of Architecture and Engineering
Architectural Services Division

MANAGING ARCHITECT: VINCENTO GORDANO, P.A.
ARCHITECT IN CHARGE: [blank]
ARCHITECT'S NAME: [blank]

C:\PROJ\ARCH\CAD\W\ACADISTW - PLEASE LEAVE THIS FILE IN ROCHES-2011.DWG A-F 12/7/2010 10:23:42 AM

FLOOR PLAN
SCALE: 1/16" = 1'-0"

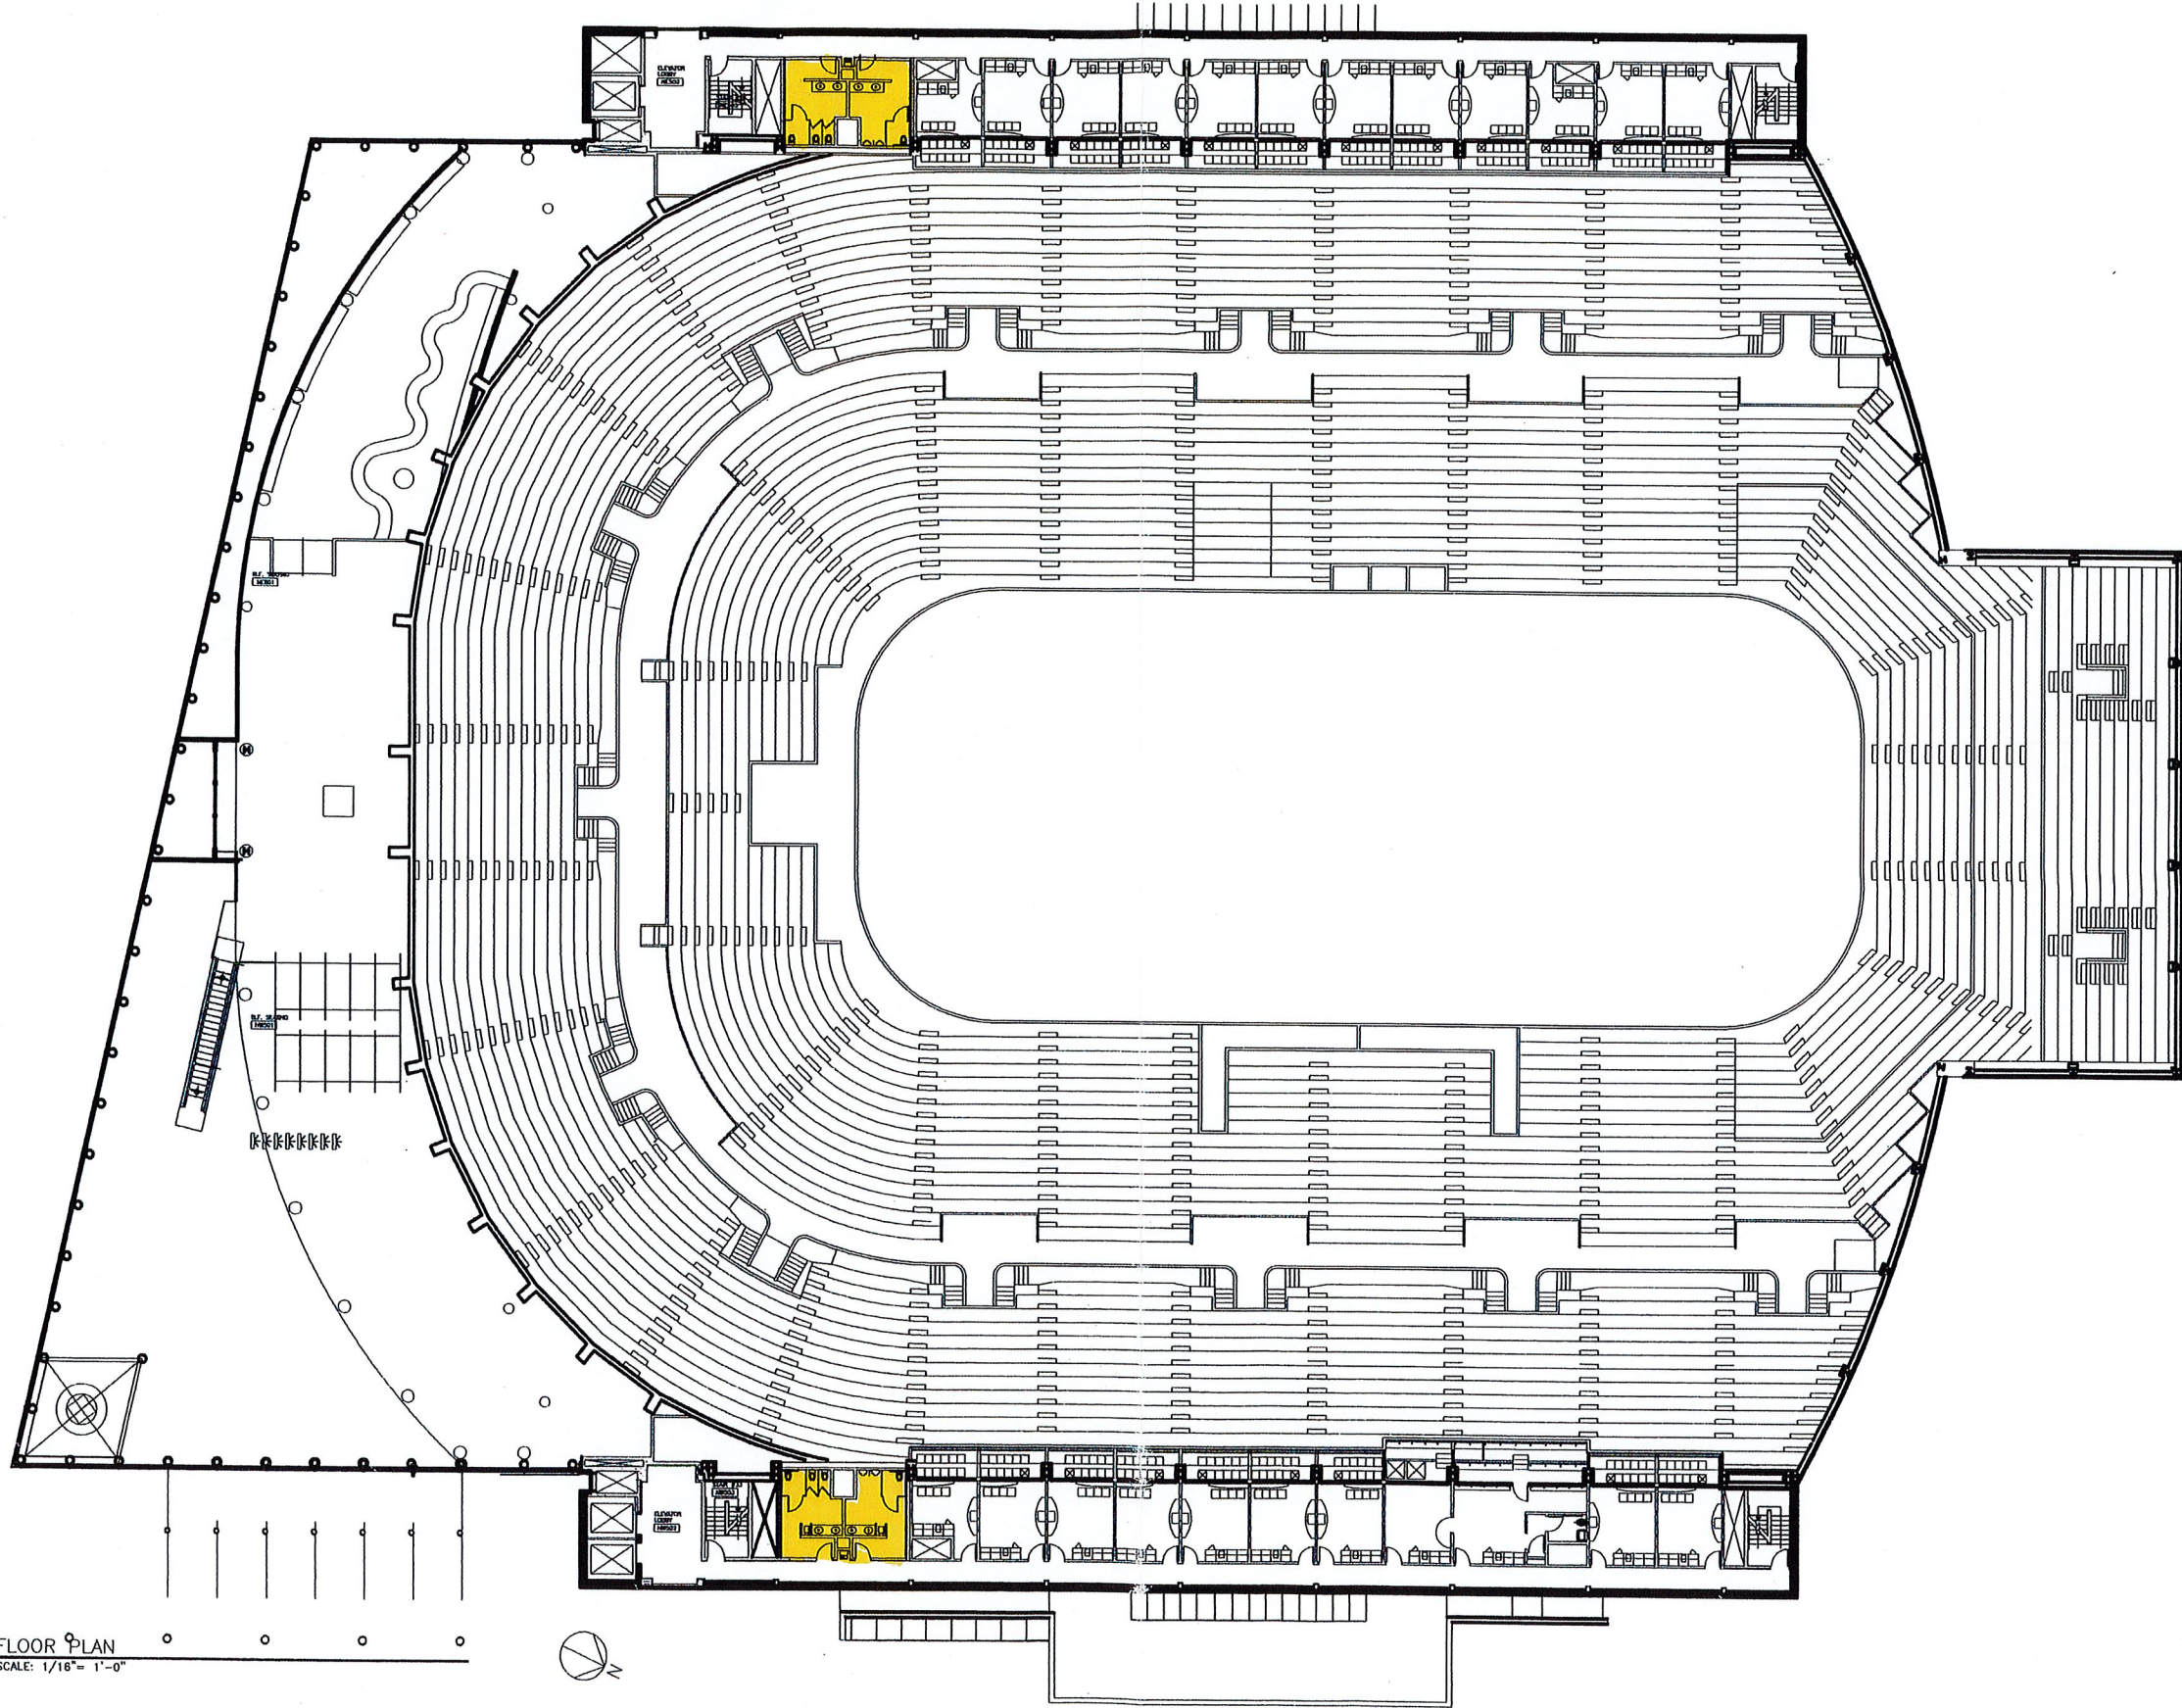

DRAWING TITLE:

LEVEL 5
FLOOR PLAN

DRAWING NO.:

A-#

OF

ISSUED: 02/04/11

CHECKED: xxx

DRAWN: amk

DESIGN: xxx

BLOC. NUMBER: 5.33

PROJECT NO.: xxxxx

NO.:

BY:

REVISIONS:

DATE:

PROJECT:

WAR MEMORIAL

ADDRESS: Rochester, NY 146XX



City of Rochester
Department of Environmental Services
Bureau of Architecture and Engineering
Architectural Services Division

ARCHITECT IN CHARGE:
MANAGING ARCHITECT

ARCHITECT'S NAME:
VINCENZO GIORDANO, RA